

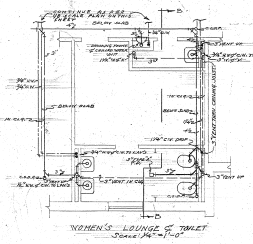
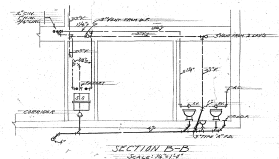


| | | | |
|-----------------------------|----------|-----------------------------|--------------|
| NATIONAL GUARD ARMYORY | | SMITHTOWN NEW YORK | |
| DESIGNED BY | J. B. R. | PROJECT NO. | 1000 |
| DRAWN BY | J. B. R. | DATE | MAR 11, 1921 |
| CHECKED BY | J. B. R. | SCALE | 1/8" = 1'-0" |
| FOUNDATION PLAN | | NEW DRILLED WELL & PUMP PIT | |
| DIVISION OF PUBLIC WORKS | | DEPARTMENT OF ARCHITECTURE | |
| CARL W. LARSON | | 3700 | |
| APPROVED BY LETTER NO. 4283 | | | |
| DATE MARCH 9, 1921 | | | |

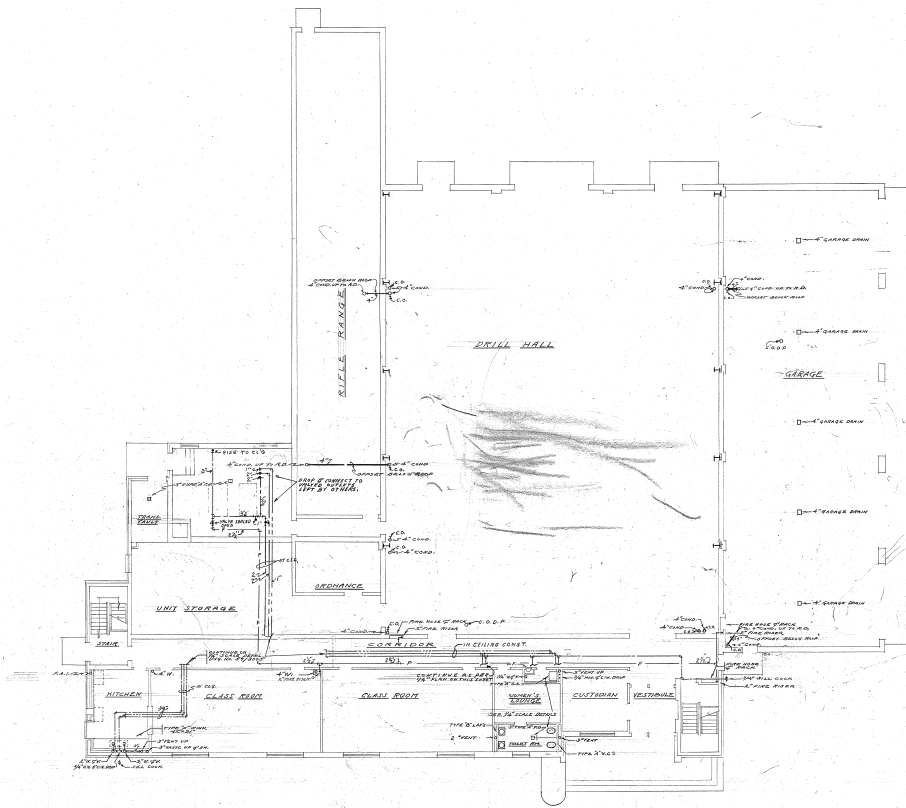

FIRST FLOOR PLAN
SCALE: 1/8" = 1'-0"

| | | | |
|-----------------------|---------------|----------------------------|----------|
| NATIONAL GUARD ARMORY | | SMITHTOWN | NEW YORK |
| DESIGNED BY | J.M.C. | SANITARY | |
| APPROVED BY | H. S. B. | ONE UNIT ARMORY | |
| DESIGNED BY | H. S. B. | FIRST FLOOR PLAN | |
| APPROVED BY | H. S. B. | DETAILS | |
| DESIGNED BY | H. S. B. | DEPARTMENT OF PUBLIC WORKS | |
| APPROVED BY | H. S. B. | DIVISION OF ARCHITECTURE | |
| DATE | MARCH 9, 1860 | NO. 1 | 15002 |

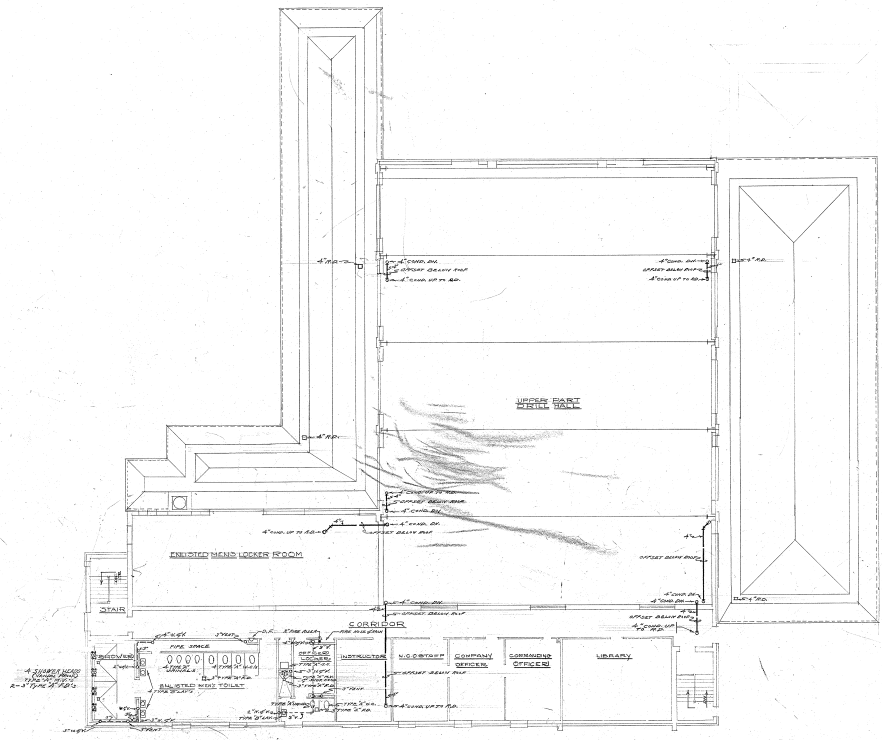

SECOND FLOOR PLAN
SCALE: 1/8" = 1'-0"

| | | | |
|----------------------------|-----------------|-------------|---------------|
| NATIONAL GUARD ARMORY | | PROJECT NO. | |
| SMITHTOWN | NEW YORK | DATE | |
| DESIGNED BY | SANITARY | APPROVED BY | |
| DRAWN BY | ONE UNIT ARMORY | DATE | 12-27-33 |
| CHECKED BY | | DATE | DEC 13, 1934 |
| SECOND FLOOR PLAN | | NO. | 53/3003 |
| STATE OF NEW YORK | | DATE | |
| DEPARTMENT OF PUBLIC WORKS | | DATE | |
| DIVISION OF ARCHITECTURE | | DATE | |
| APPROVED BY | | LETTER NO. | 6848 |
| DATE | | | MARCH 2, 1934 |